


# LINCOLN PARKWAY



SEE PLAN P-2344 FOR LINCOLN PRWY IMPROVEMENTS

## PHASE I

PAD 659.90  
F.F. 660.50

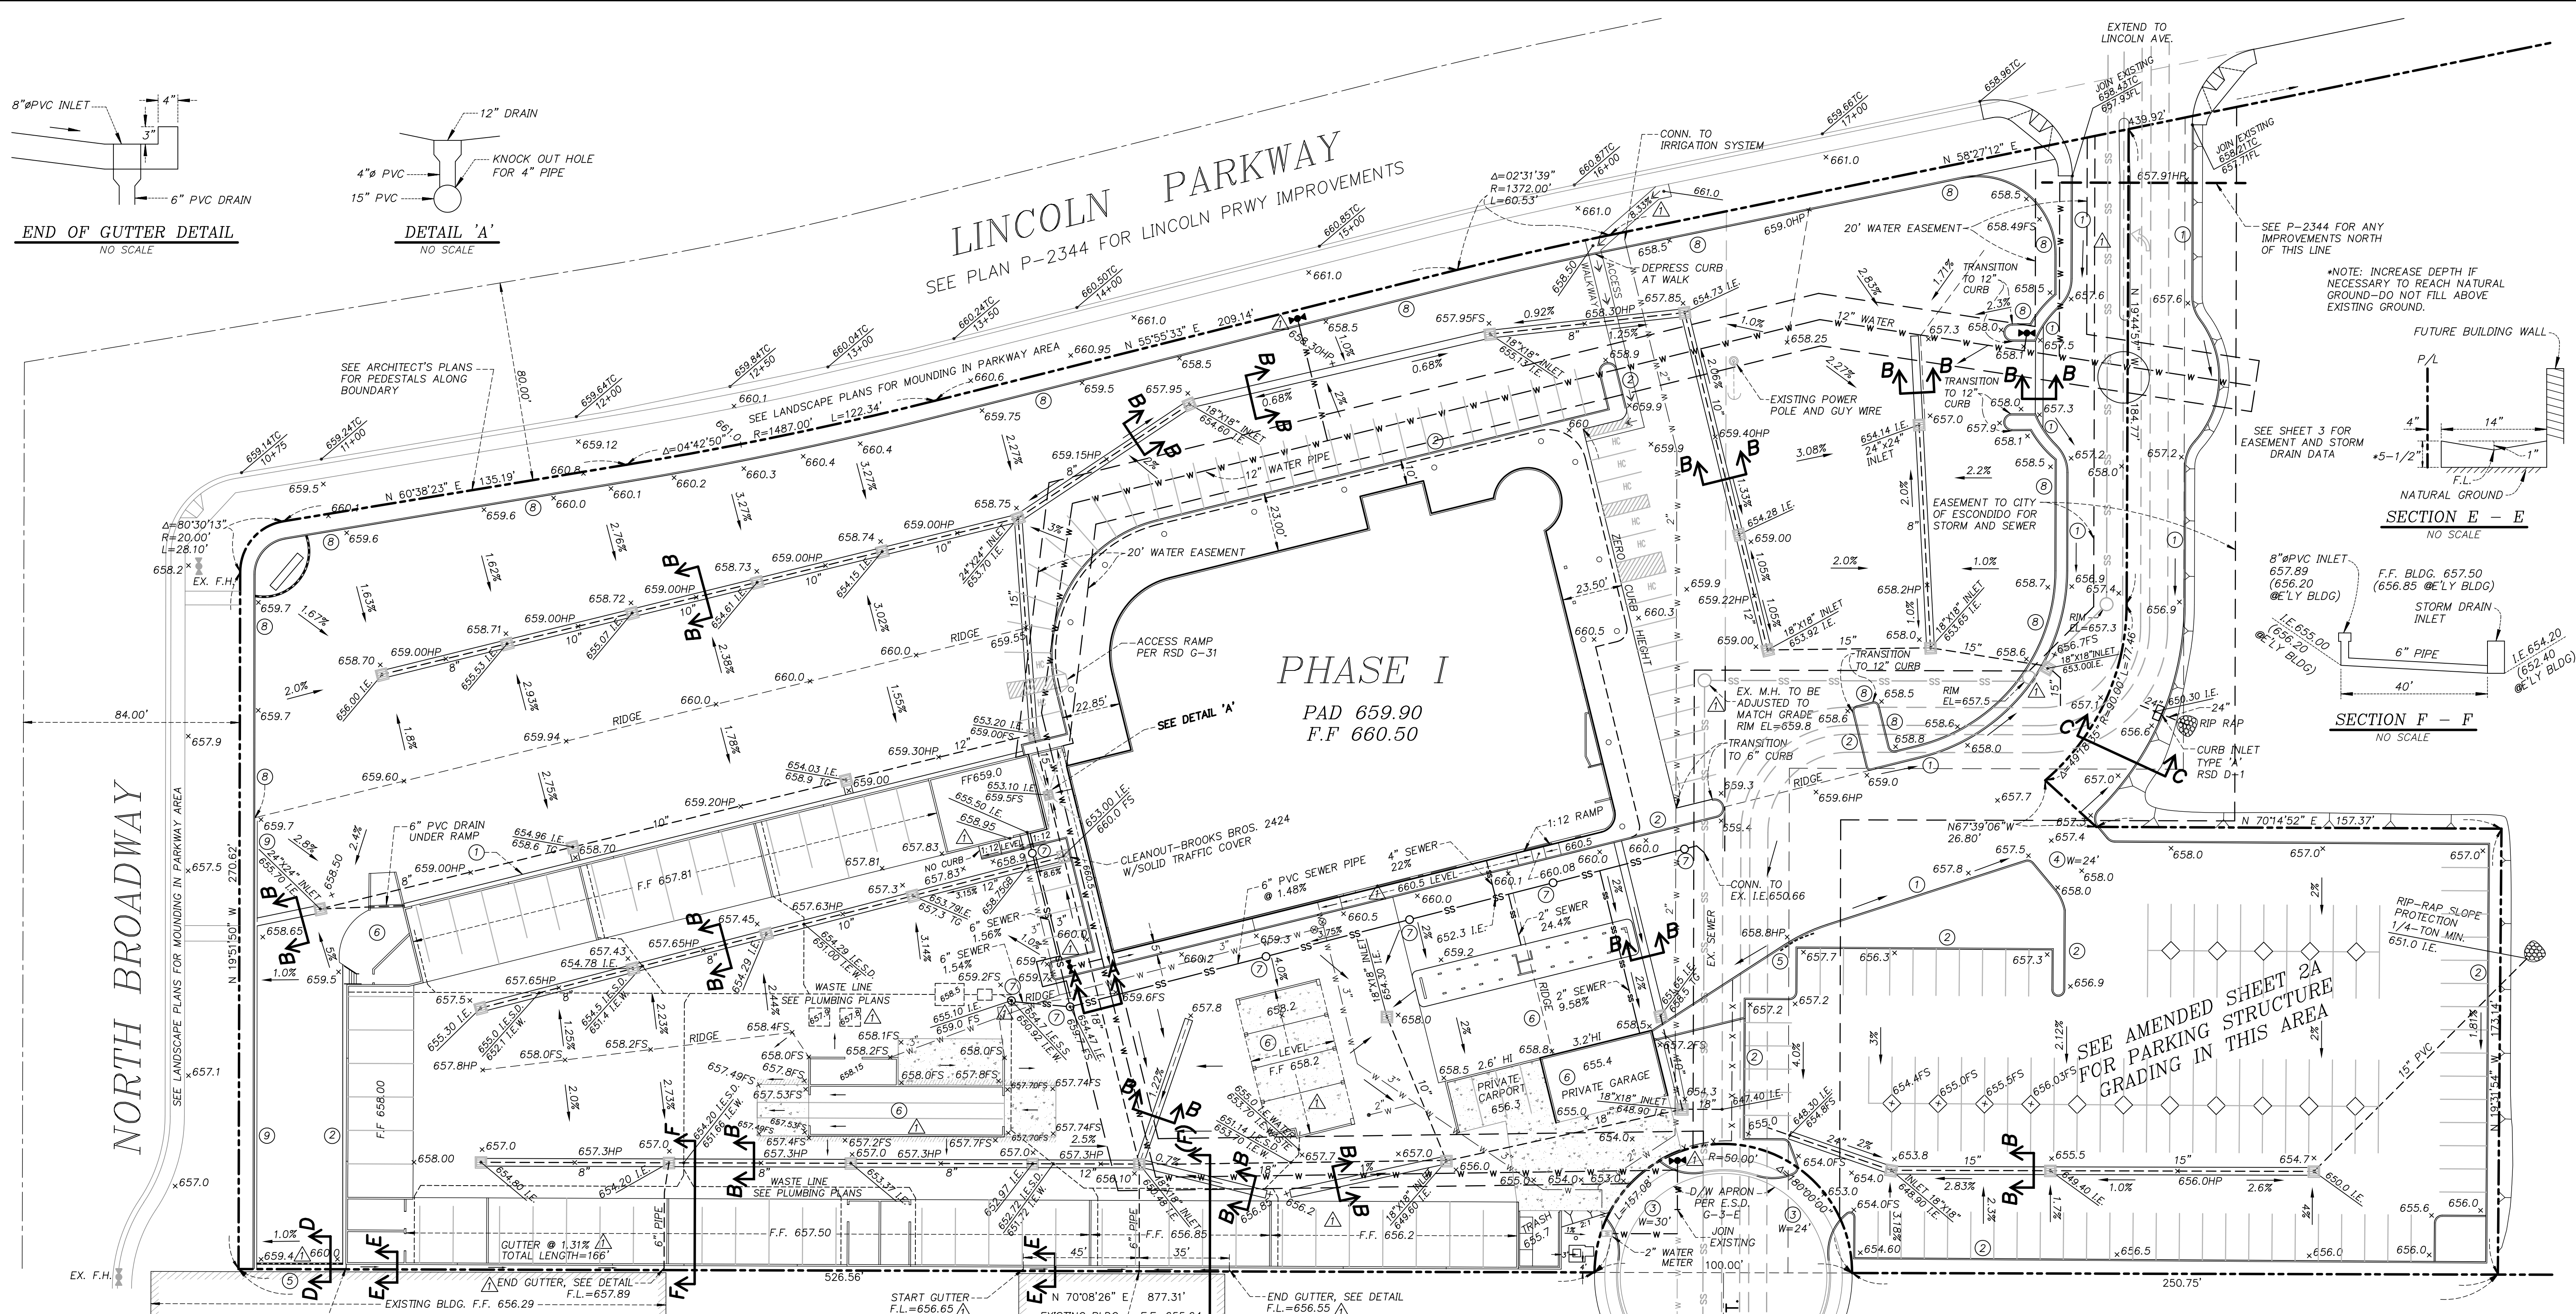


NOTE: INCREASE DEPTH IF NECESSARY TO REACH NATURAL GROUND—DO NOT FILL ABOVE EXISTING GROUND.

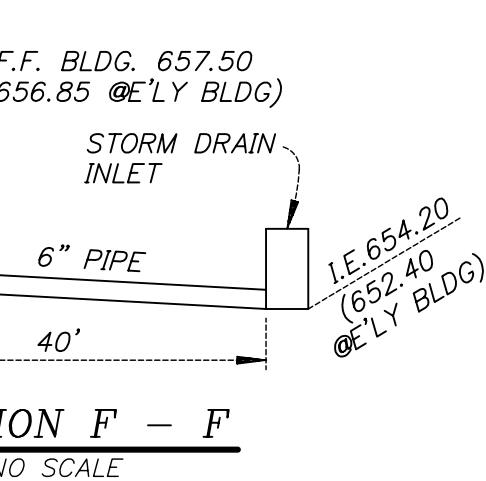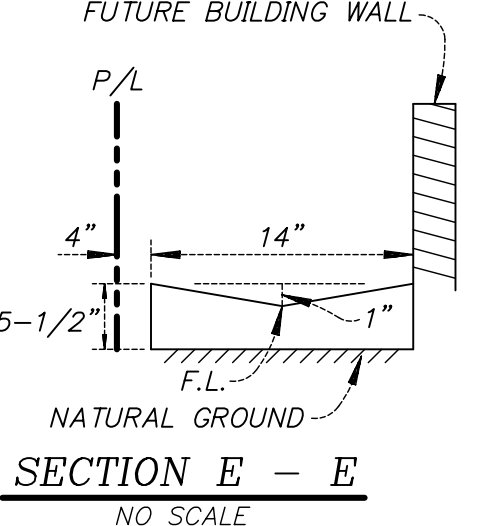

SEE AMENDED SHEET 2A FOR PARKING STRUCTURE GRADING IN THIS AREA



DIGALERT

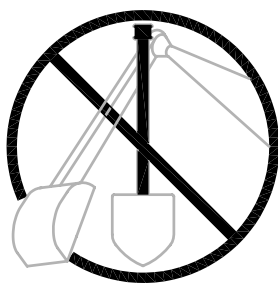

CALL BEFORE YOU DIG

1-800-227-2800

 
48 HOURS NOTICE REQUIRED

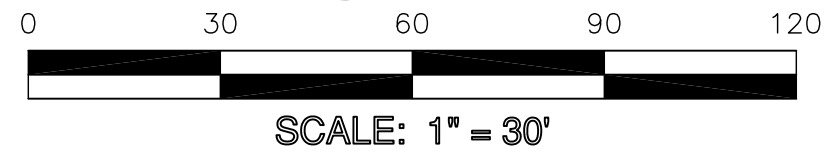

NOTES:  
ALL INLETS ARE 12"X12" UNLESS NOTED OTHERWISE.  
ALL INLETS TO HAVE FOSSIL FILTERS.  
THIS DRAWING DOES NOT COVER WASTE LINES. SEE PLUMBING PLANS FOR DETAILS OF WASTE LINES.

### LEGEND

- ① 6" CURB & GUTTER PER RSD G-2
- ② 6" CURB ONLY PER RSD G-1
- ③ ALLEY TYPE DRIVEWAY PER ESCONDIDO STD. DWG. G-3-E
- ④ CONCRETE DRIVEWAY PER RSD G-14B, W=24"
- ⑤ RETAINING WALL TYPE 'C' PER RSD C-9
- ⑥ SEE ARCHITECT'S PLANS FOR DETAILS
- ⑦ SEWER CLEANOUT
- ⑧ 12" CURB ONLY PER RSD G-1 MODIFIED
- ⑨ 12" CURB & GUTTER PER RSD G-2 MODIFIED
- w- 3" PRIVATE WATER LINES
- W- 12" PUBLIC WATER LINES PER W-1605
- /// AREAS OF ELEVATION DIFFERENCE

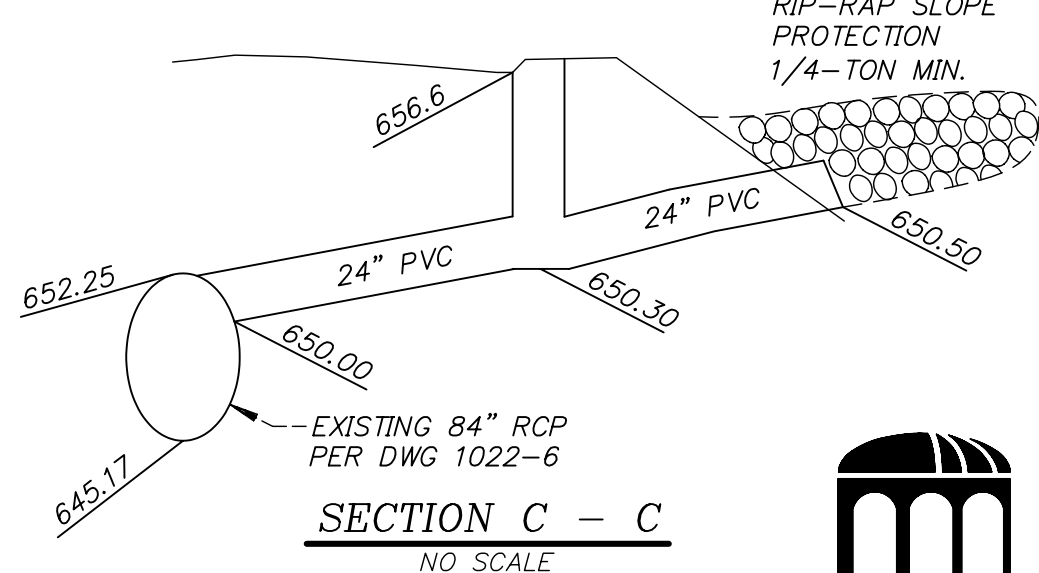

CONSTRUCTION RECORD		REFERENCES		Date	By	REVISIONS	App'd	Date	BENCH MARK	EARTHWORK QUANTITIES	SCALE	Office	Designed By	Drawn By	Checked By	CITY OF ESCONDIDO	DEPT OF PUBLIC WORKS	Drawing No.
Contractor	1507					① Driveway Alignment, Car Wash, new grades			DESCRIPTION: CHISELED "C" IN MIDDLE OF CURB RETURN S.W. COR. OF LINCOLN & GAMBLE	CUT: C.Y.	Horizontal	Filmed	Plans Prepared Under Supervision Of			GRADING PLAN:		
Inspector	1022								133-B	FILL: C.Y.	Vertical	Traffic	Date			TOYOTA OF ESCONDIDO		
Date Completed									Bench Mark No. 657.04	BALANCE: C.Y.			R.C.E. No.					Sheet 2 of 4